



UNDER REVISION

KHANDALLAH POOL REFURBISHMENT


POOL WATER SERVICES

Prepared for: WELLINGTON CITY COUNCIL
Prepared by: BECA
At: 45 WOODMANCOTE ROAD, KHANDALLAH.

Project No.: 4294564
07 05 2025
CONCEPT DESIGN

POOL WATER SERVICES DRAWING LIST	
DRG. No.	DRAWING NAME
POOL WATER SERVICES	
BWK-0000	COVER SHEET
BWK-1001	SITE PLAN
BWK-1002	EXISTING & DEMOLITION LAYOUT
BWK-1003	PROPOSED LAYOUT OPTION 1 SINGLE STOREY
BWK-1004	PROPOSED LAYOUT OPTION 2 - SINGLE STOREY
BWK-2001	CONCEPTUAL PROPOSED POOL LAYOUT
BWK-4000	CONCEPTUAL PROPOSED POOL PLANT ROOM VIEW
BWK-4001	CONCEPTUAL PROPOSED POOL PLANT ROOM LAYOUT
BWK-4002	CONCEPTUAL PROPOSED PLANT ROOM SECTIONS

make
everyday
better.

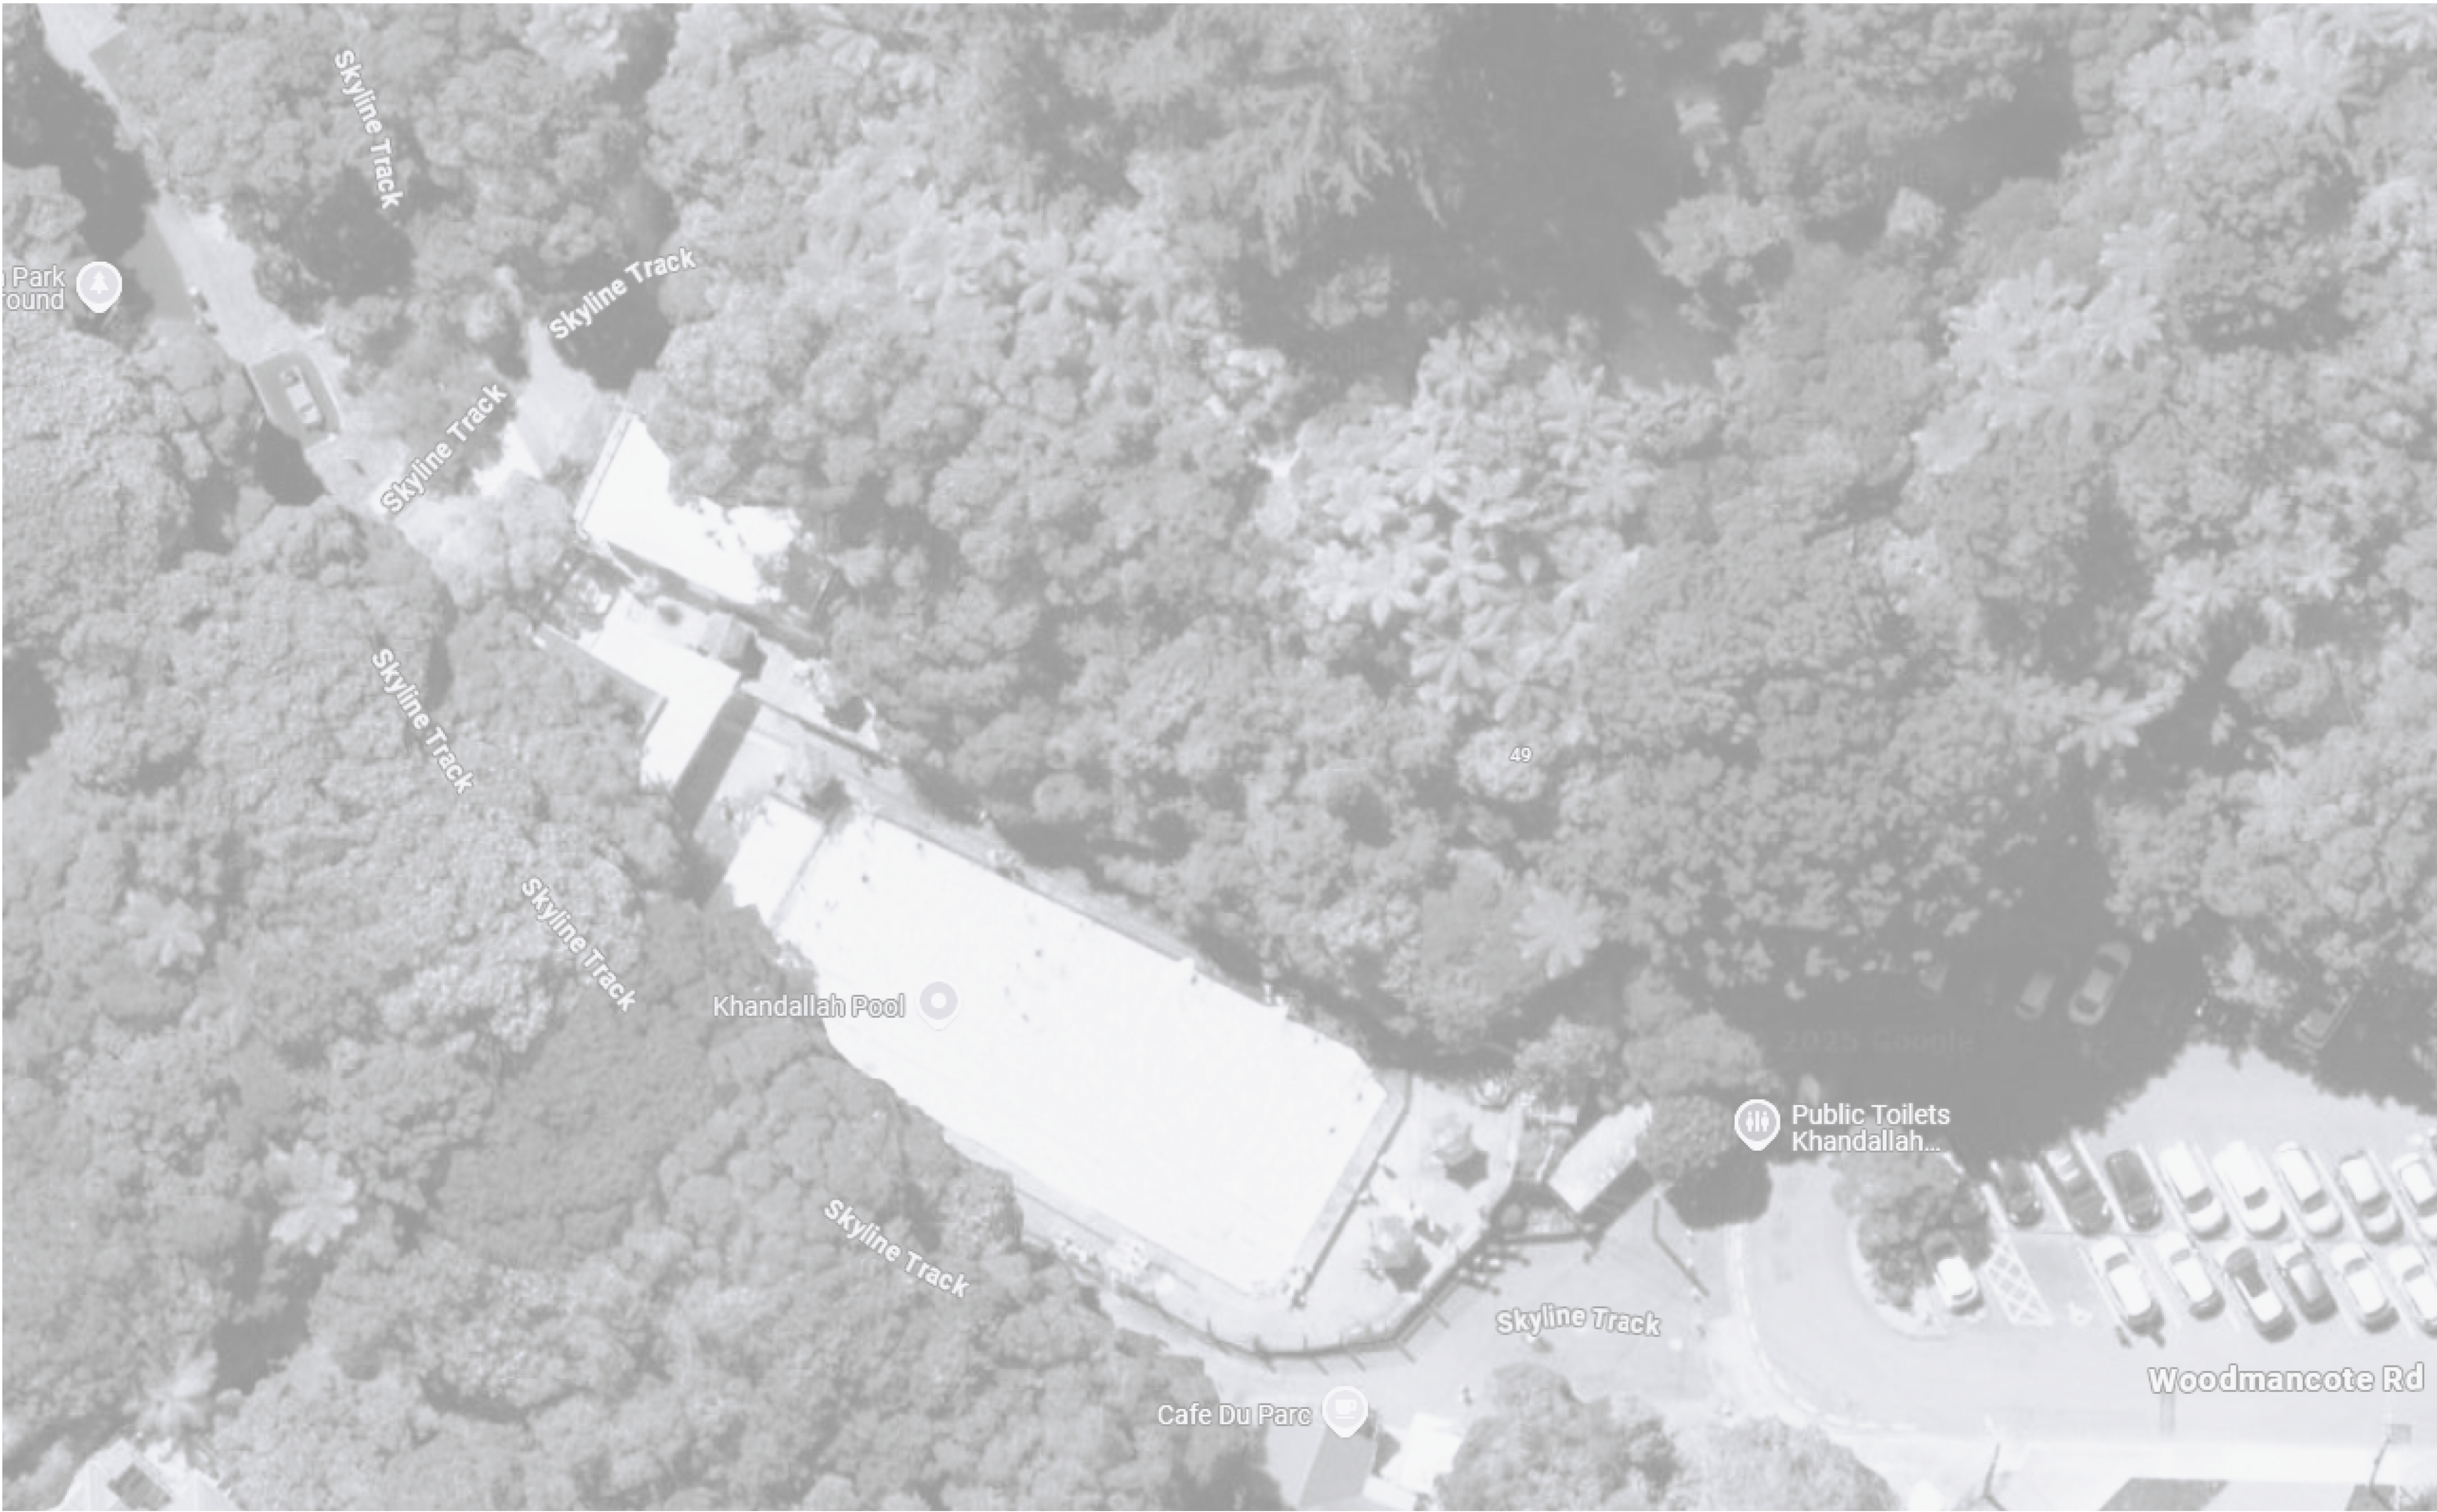

No.	Revision	By	Chk	Appd	Date


Original Scale (A1)	Design			
	Drawn			
Reduced Scale (A3)	Disg Verifier			
	Drg Check			



Client:	Absolutely Positively Wellington City Council Me Heke Ki Pōneke	Project:	KHANDALLAH POOL REFURBISHMENT 45 WOODMANCOTE ROAD, KHANDALLAH.
---------	---	----------	--

Title:	SITE PLAN
--------	------------------

Discipline		POOL WATER SERVICES	
Drawing No.		4294564-BWK-1001	Rev.

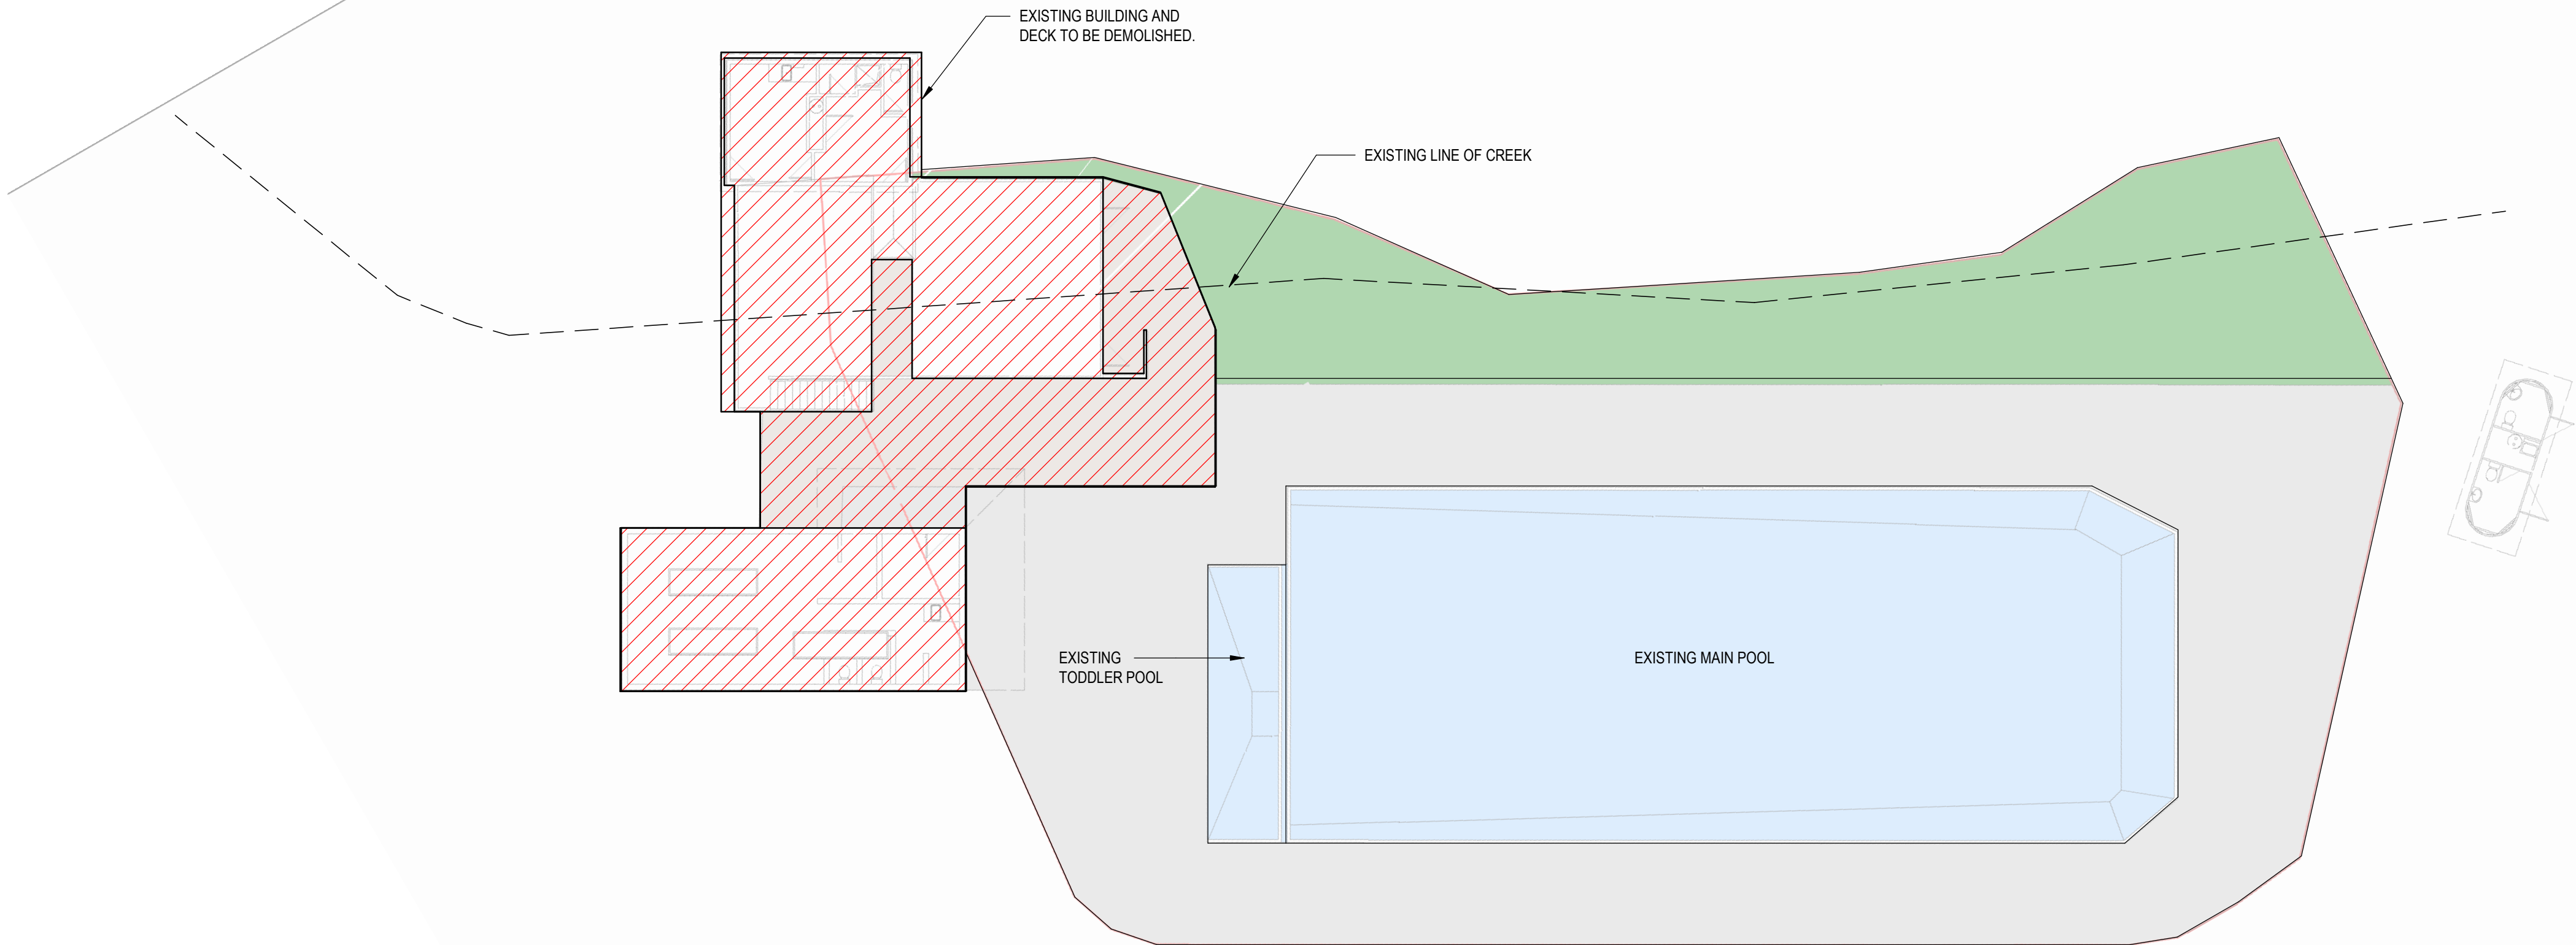

No.	Revision	By	Chk	Appd	Date


Original Scale (A1)	Design			
	Drawn			
Reduced Scale (A3)	Disg Verifier			
	Drg Check			



Client:	Absolutely Positively Wellington City Council Me Heke Ki Pōneke	Project:	KHANDALLAH POOL REFURBISHMENT 45 WOODMANCOTE ROAD, KHANDALLAH.
---------	---	----------	--

Title:	EXISTING & DEMOLITION LAYOUT	Discipline:	POOL WATER SERVICES
		Drawing No.:	4294564-BWK-1002
		Rev.:	

DRAFT ONLY
CUSTOM COMMENTS

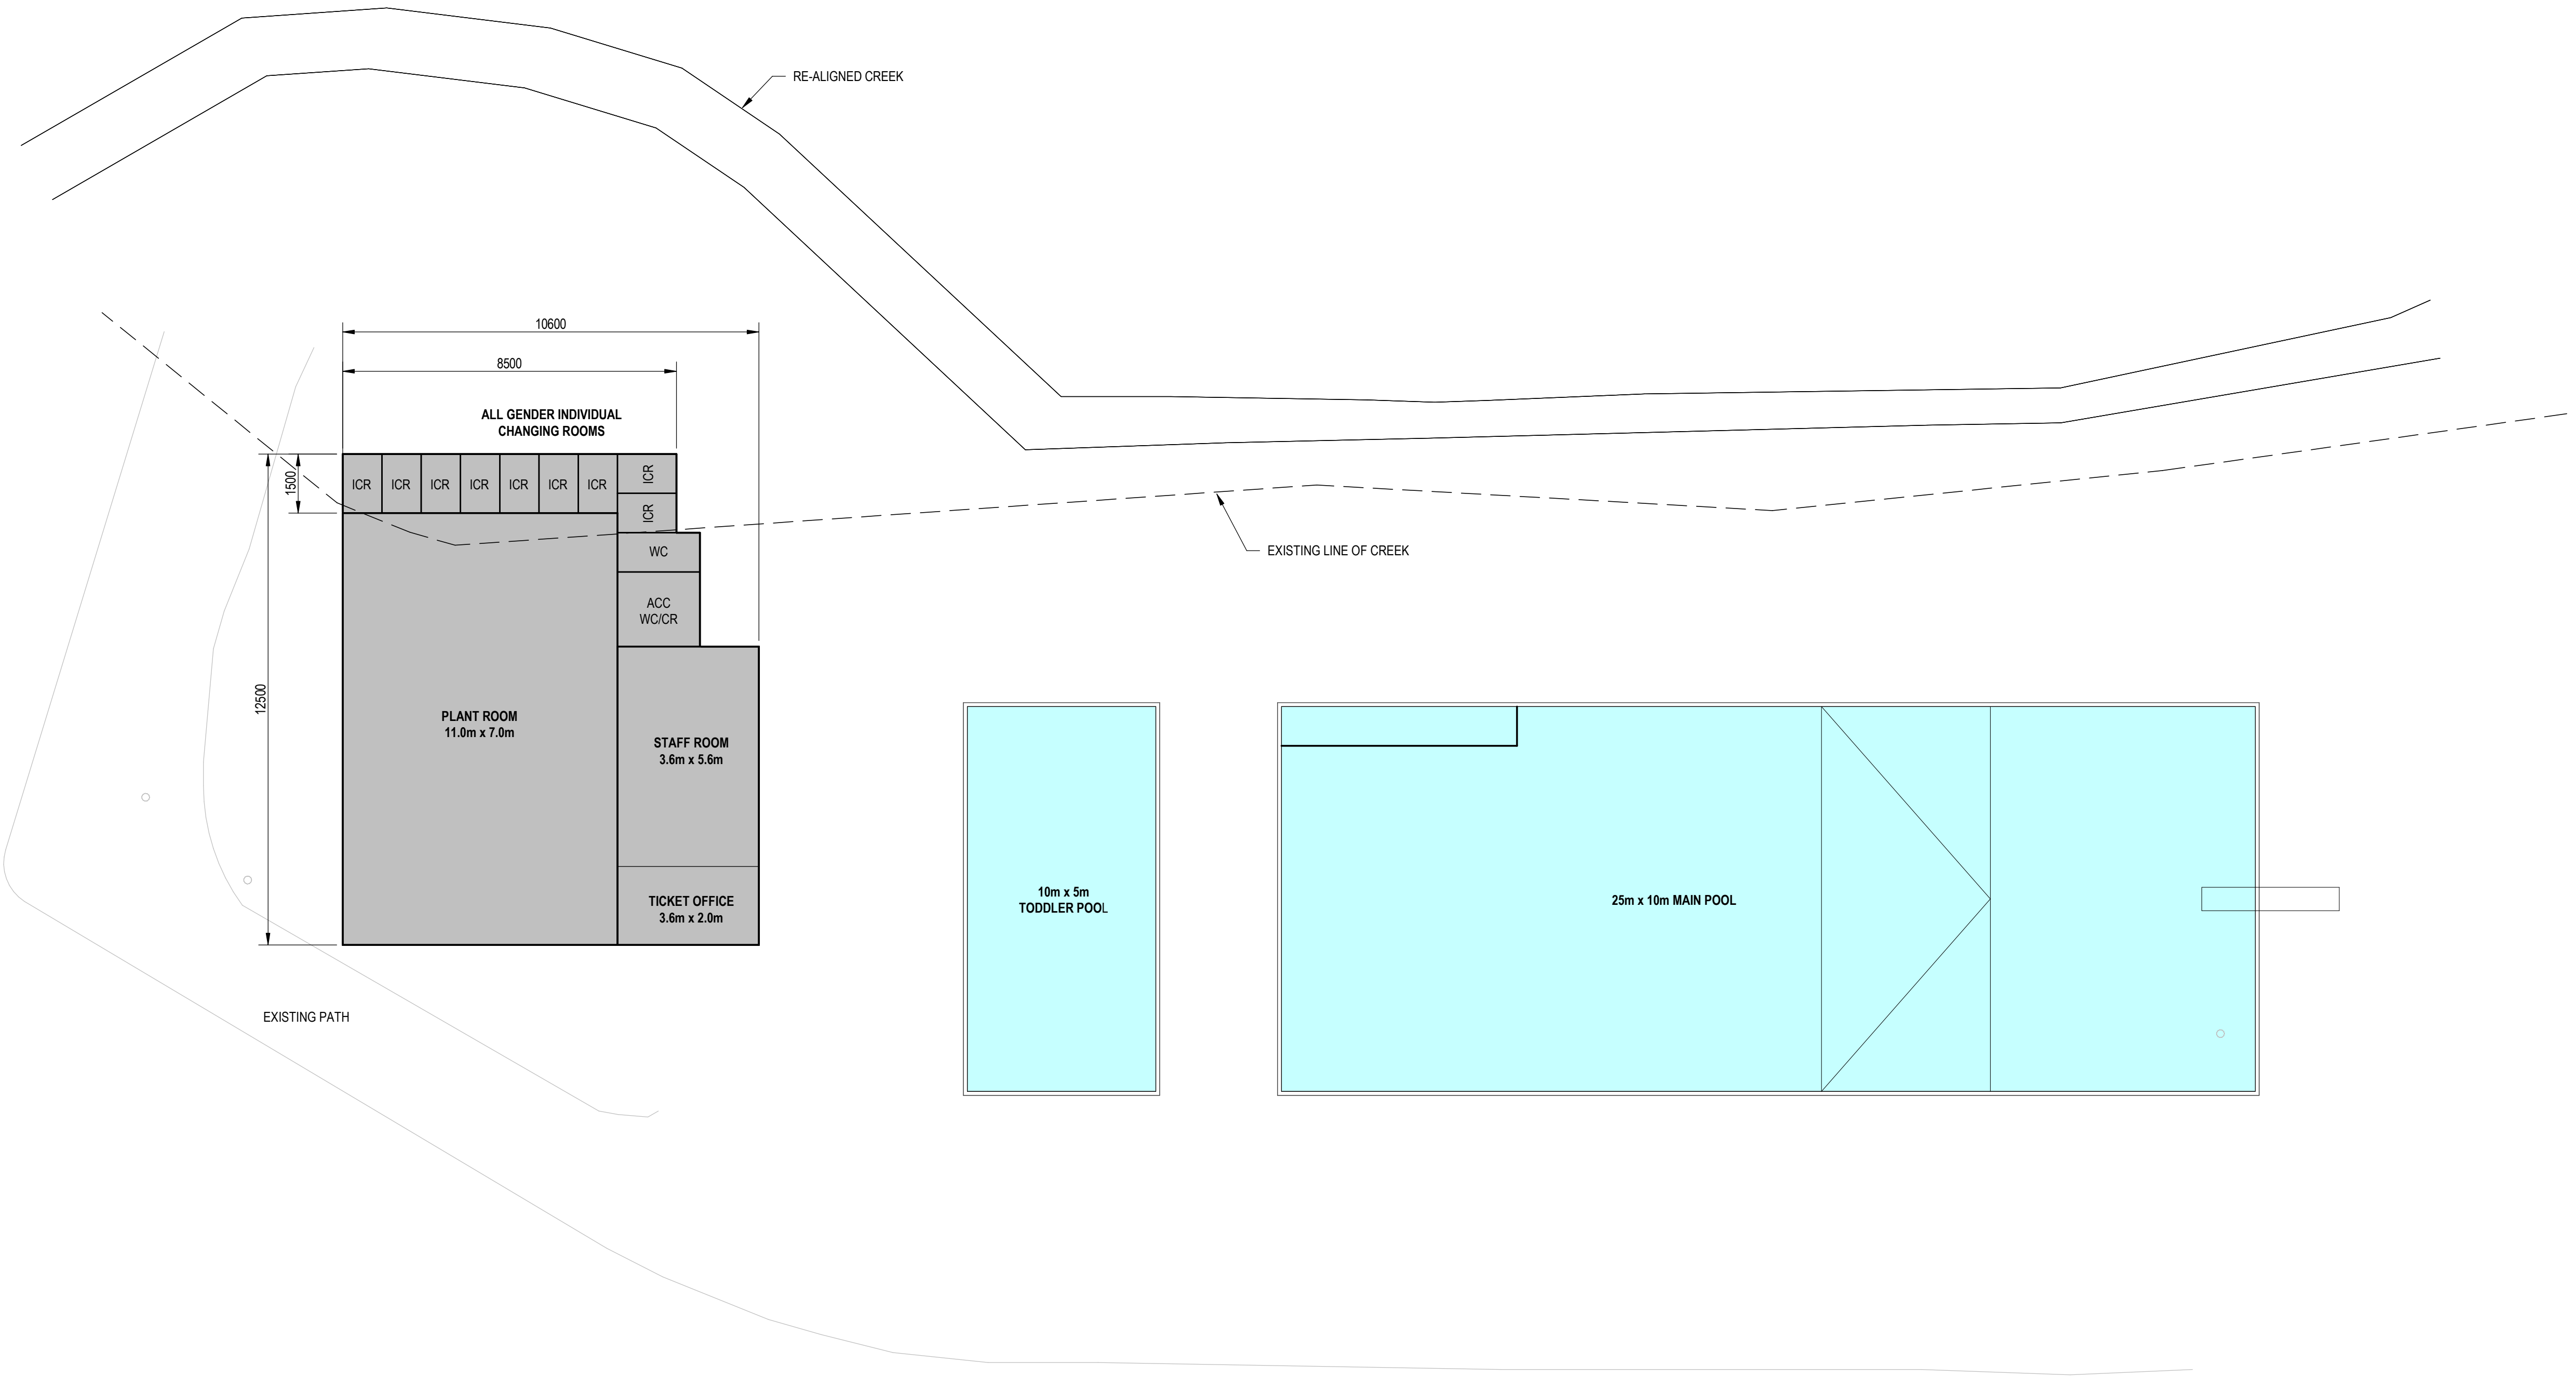

No.	Revision		By	Chk	Appd
					Date


Original Scale (A1)	Design			
	Drawn			
Reduced Scale (A3)	Disg Verifier			
	Drg Check			



Client:	Absolutely Positively Wellington City Council Me Heke Ki Pōneke	Project:	KHANDALLAH POOL REFURBISHMENT 45 WOODMANCOTE ROAD, KHANDALLAH.
---------	---	----------	--

Title:	PROPOSED LAYOUT OPTION 1 SINGLE STOREY
--------	---

Discipline:	POOL WATER SERVICES
Drawing No:	4294564-BWK-1003
Rev.	

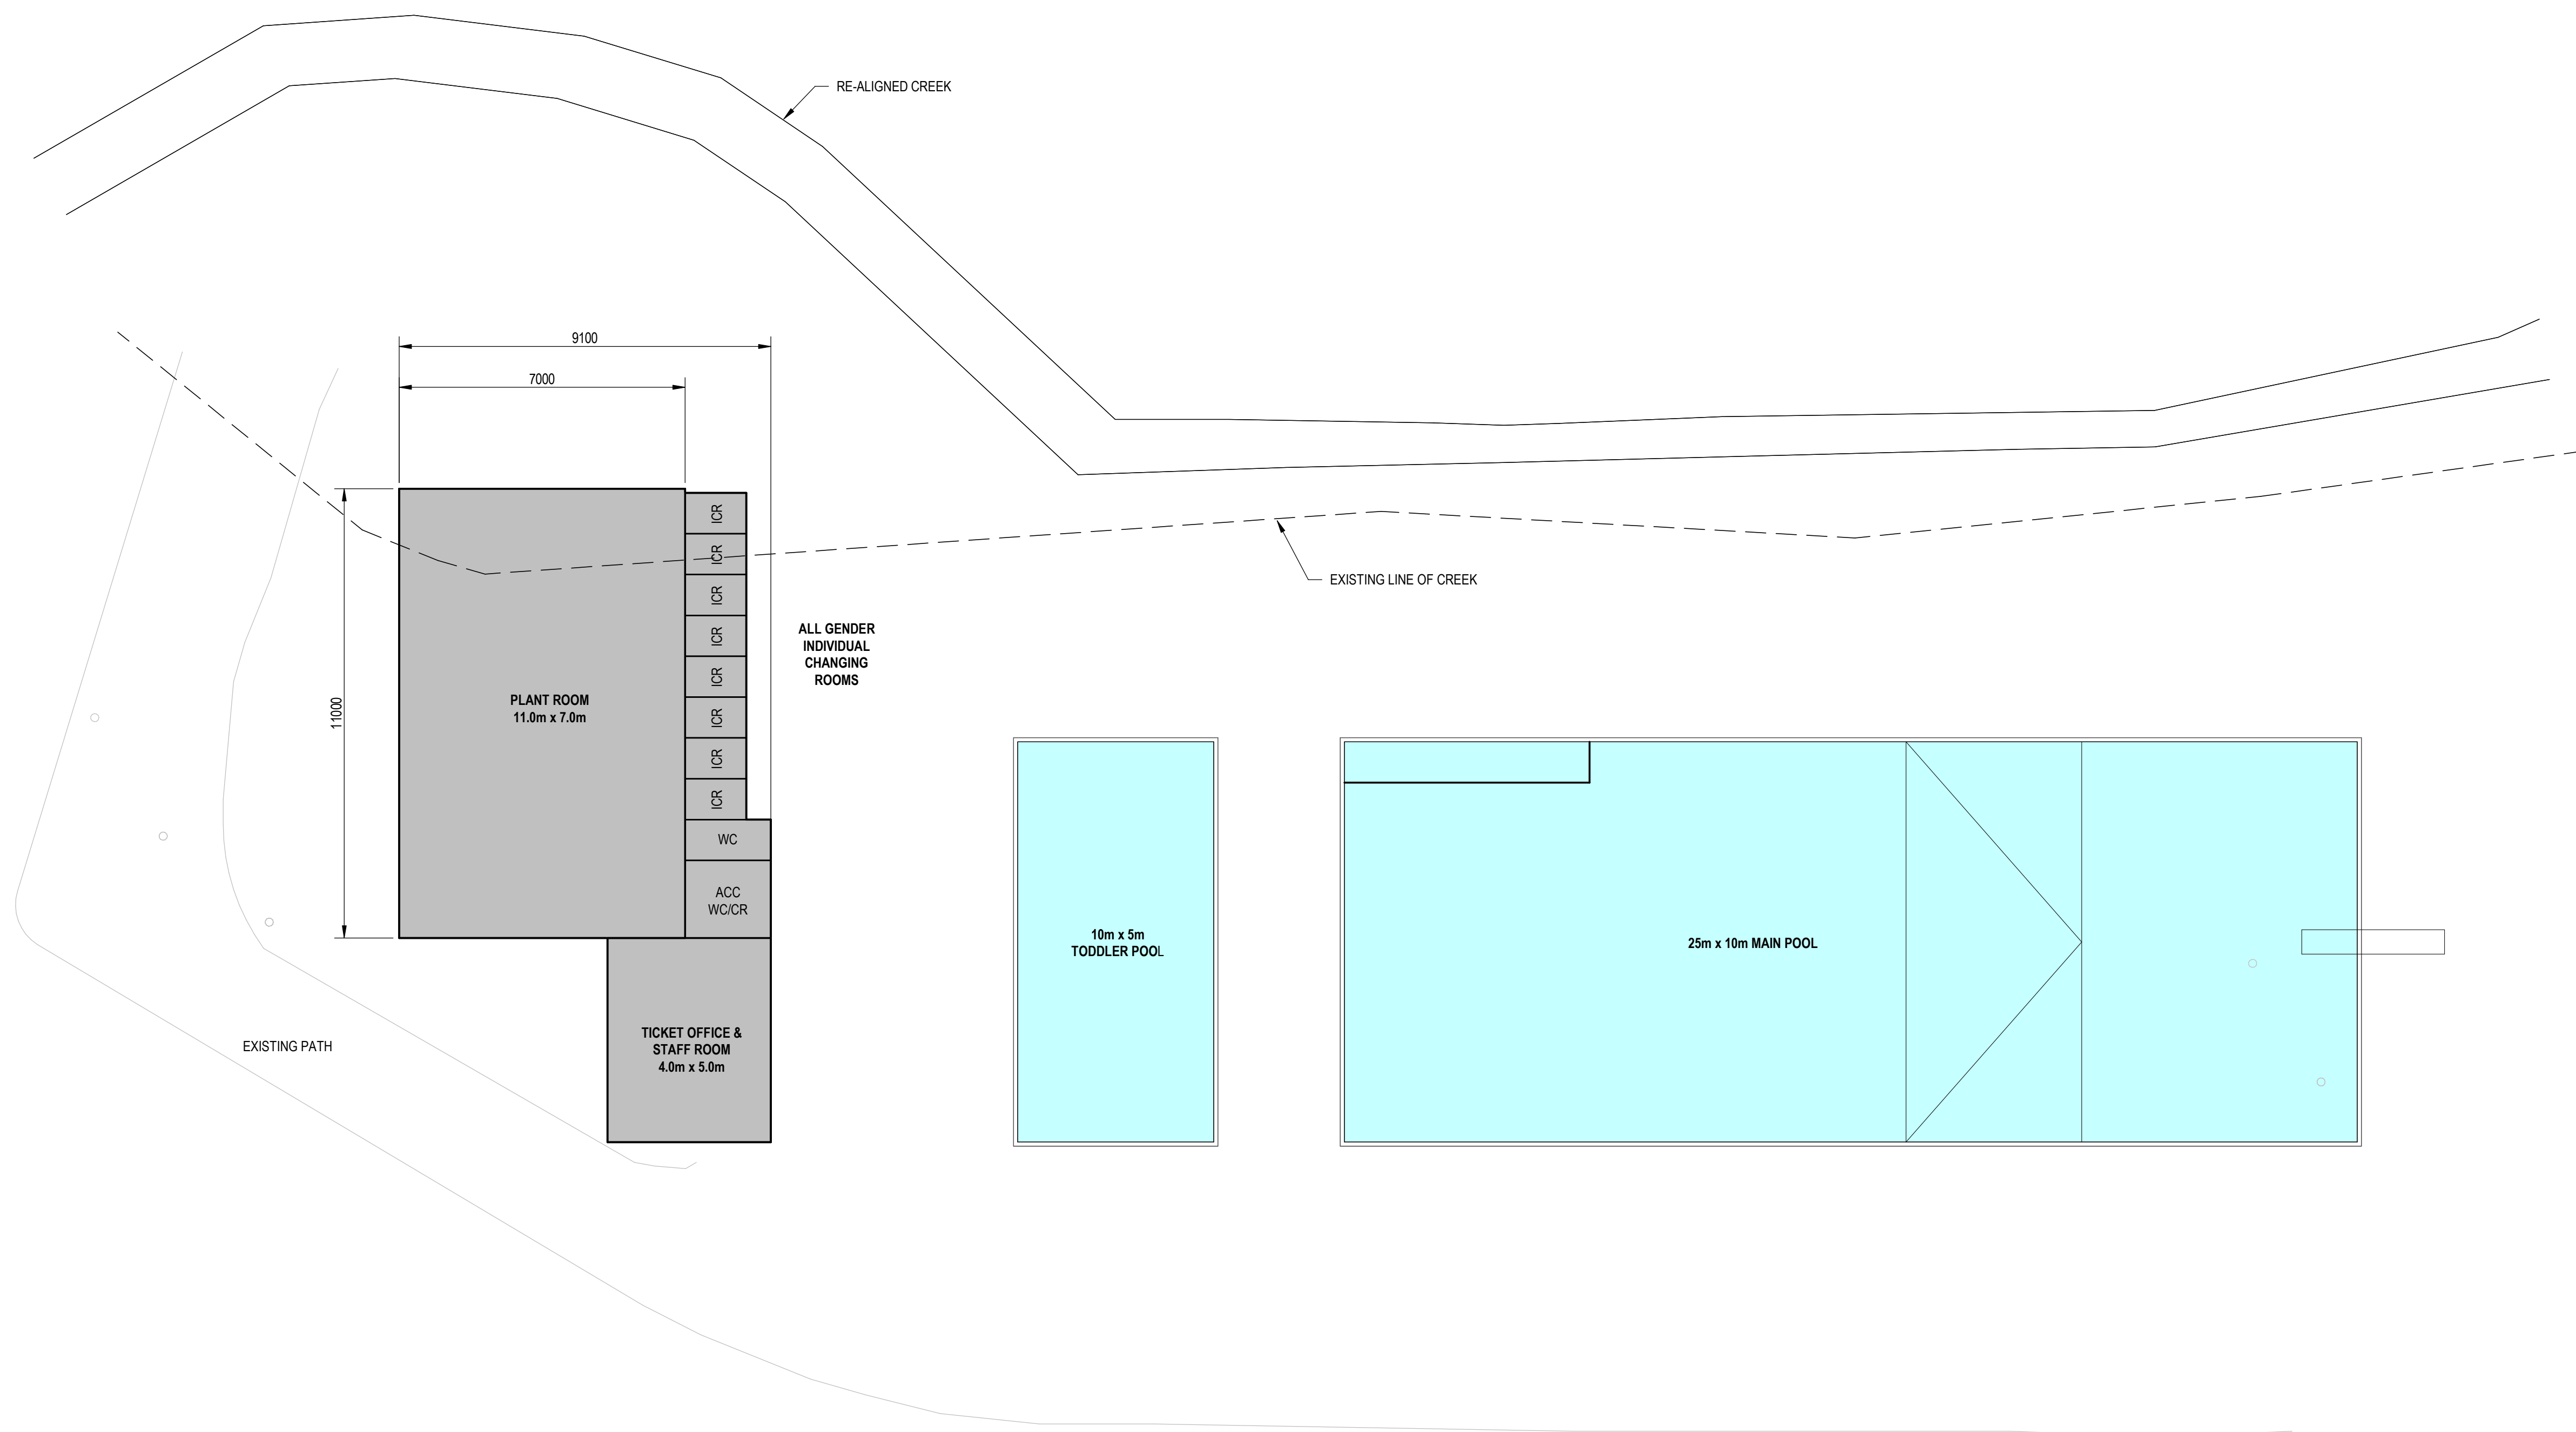

No.	Revision			By	Chk
				Appd	Date

Original Scale (A1)	Design			
	Drawn			
Reduced Scale (A3)	Disg Verifier			
	Drg Check			





Client:
Absolutely Positively Wellington City Council
Me Heke Ki Pōneke

Project:
KHANDALLAH POOL REFURBISHMENT
45 WOODMANCOTE ROAD, KHANDALLAH.

Title: PROPOSED LAYOUT OPTION 2 - SINGLE STOREY		Discipline: POOL WATER SERVICES
Drawing No: 4294564-BWK-1004		Rev.

DRAFT ONLY
CUSTOM COMMENTS

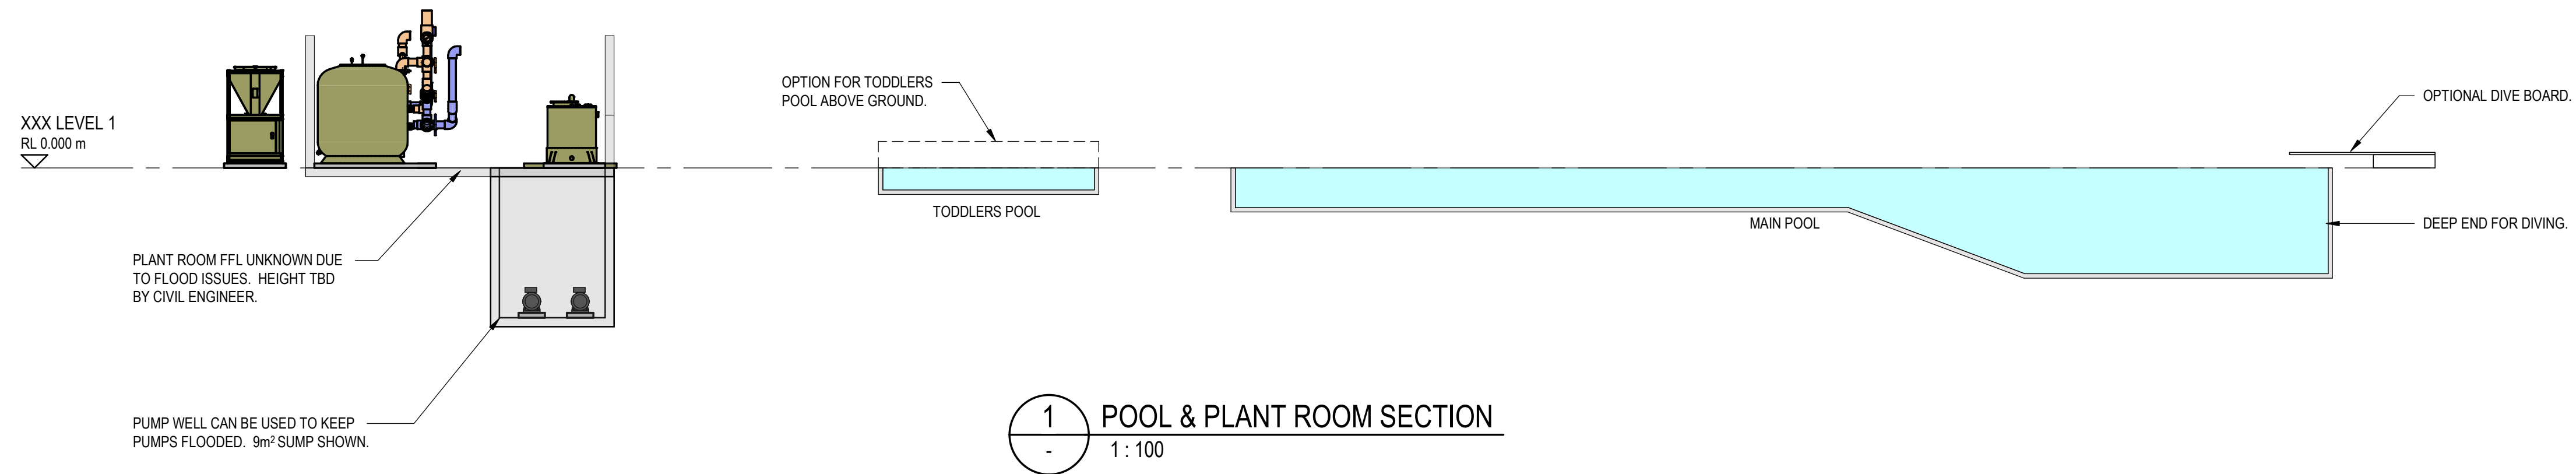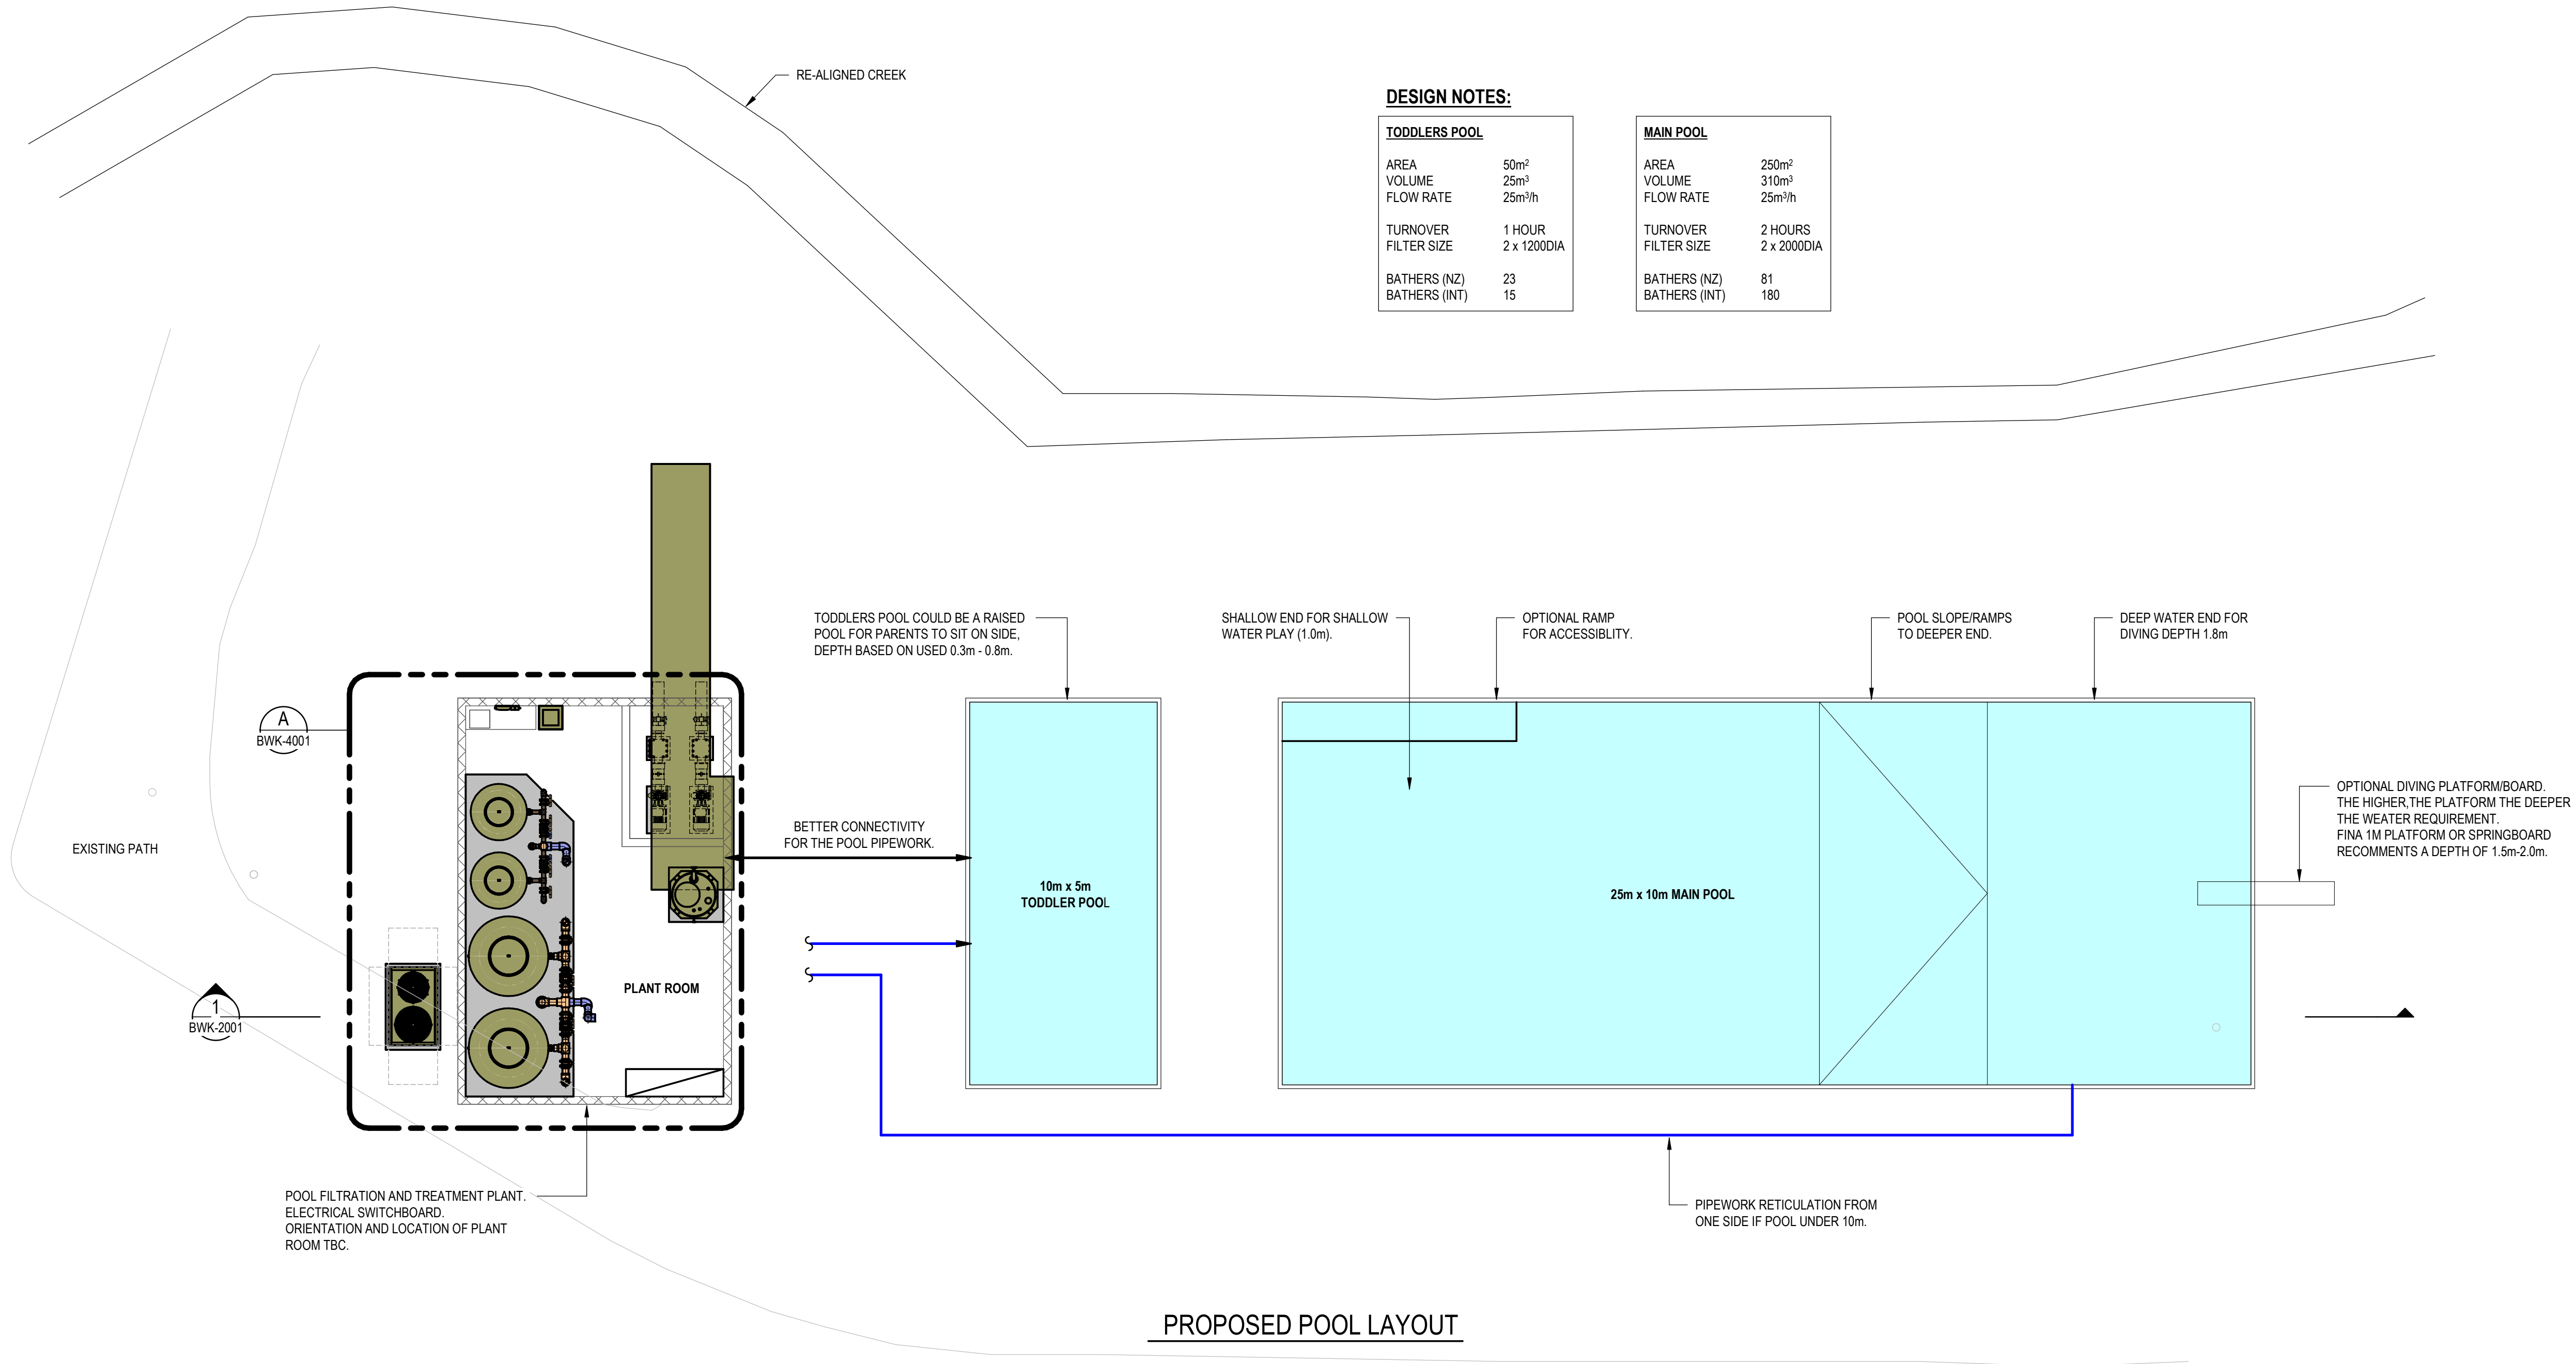

No.	Revision	By	Chk	Appd	Date

Original Scale (A1)	Design Drawn				
Reduced Scale (A3)	Disg Verifier				
	Drg Check				




Client:	Absolutely Positively Wellington City Council Me Heke Ki Pōneke
Project:	KHANDALLAH POOL REFURBISHMENT 45 WOODMANCOTE ROAD, KHANDALLAH.

Title:	CONCEPTUAL PROPOSED POOL LAYOUT
--------	------------------------------------

Discipline:	POOL WATER SERVICES
Drawing No:	4294564-BWK-2001
Rev.	

DRAFT ONLY
CUSTOM COMMENTS

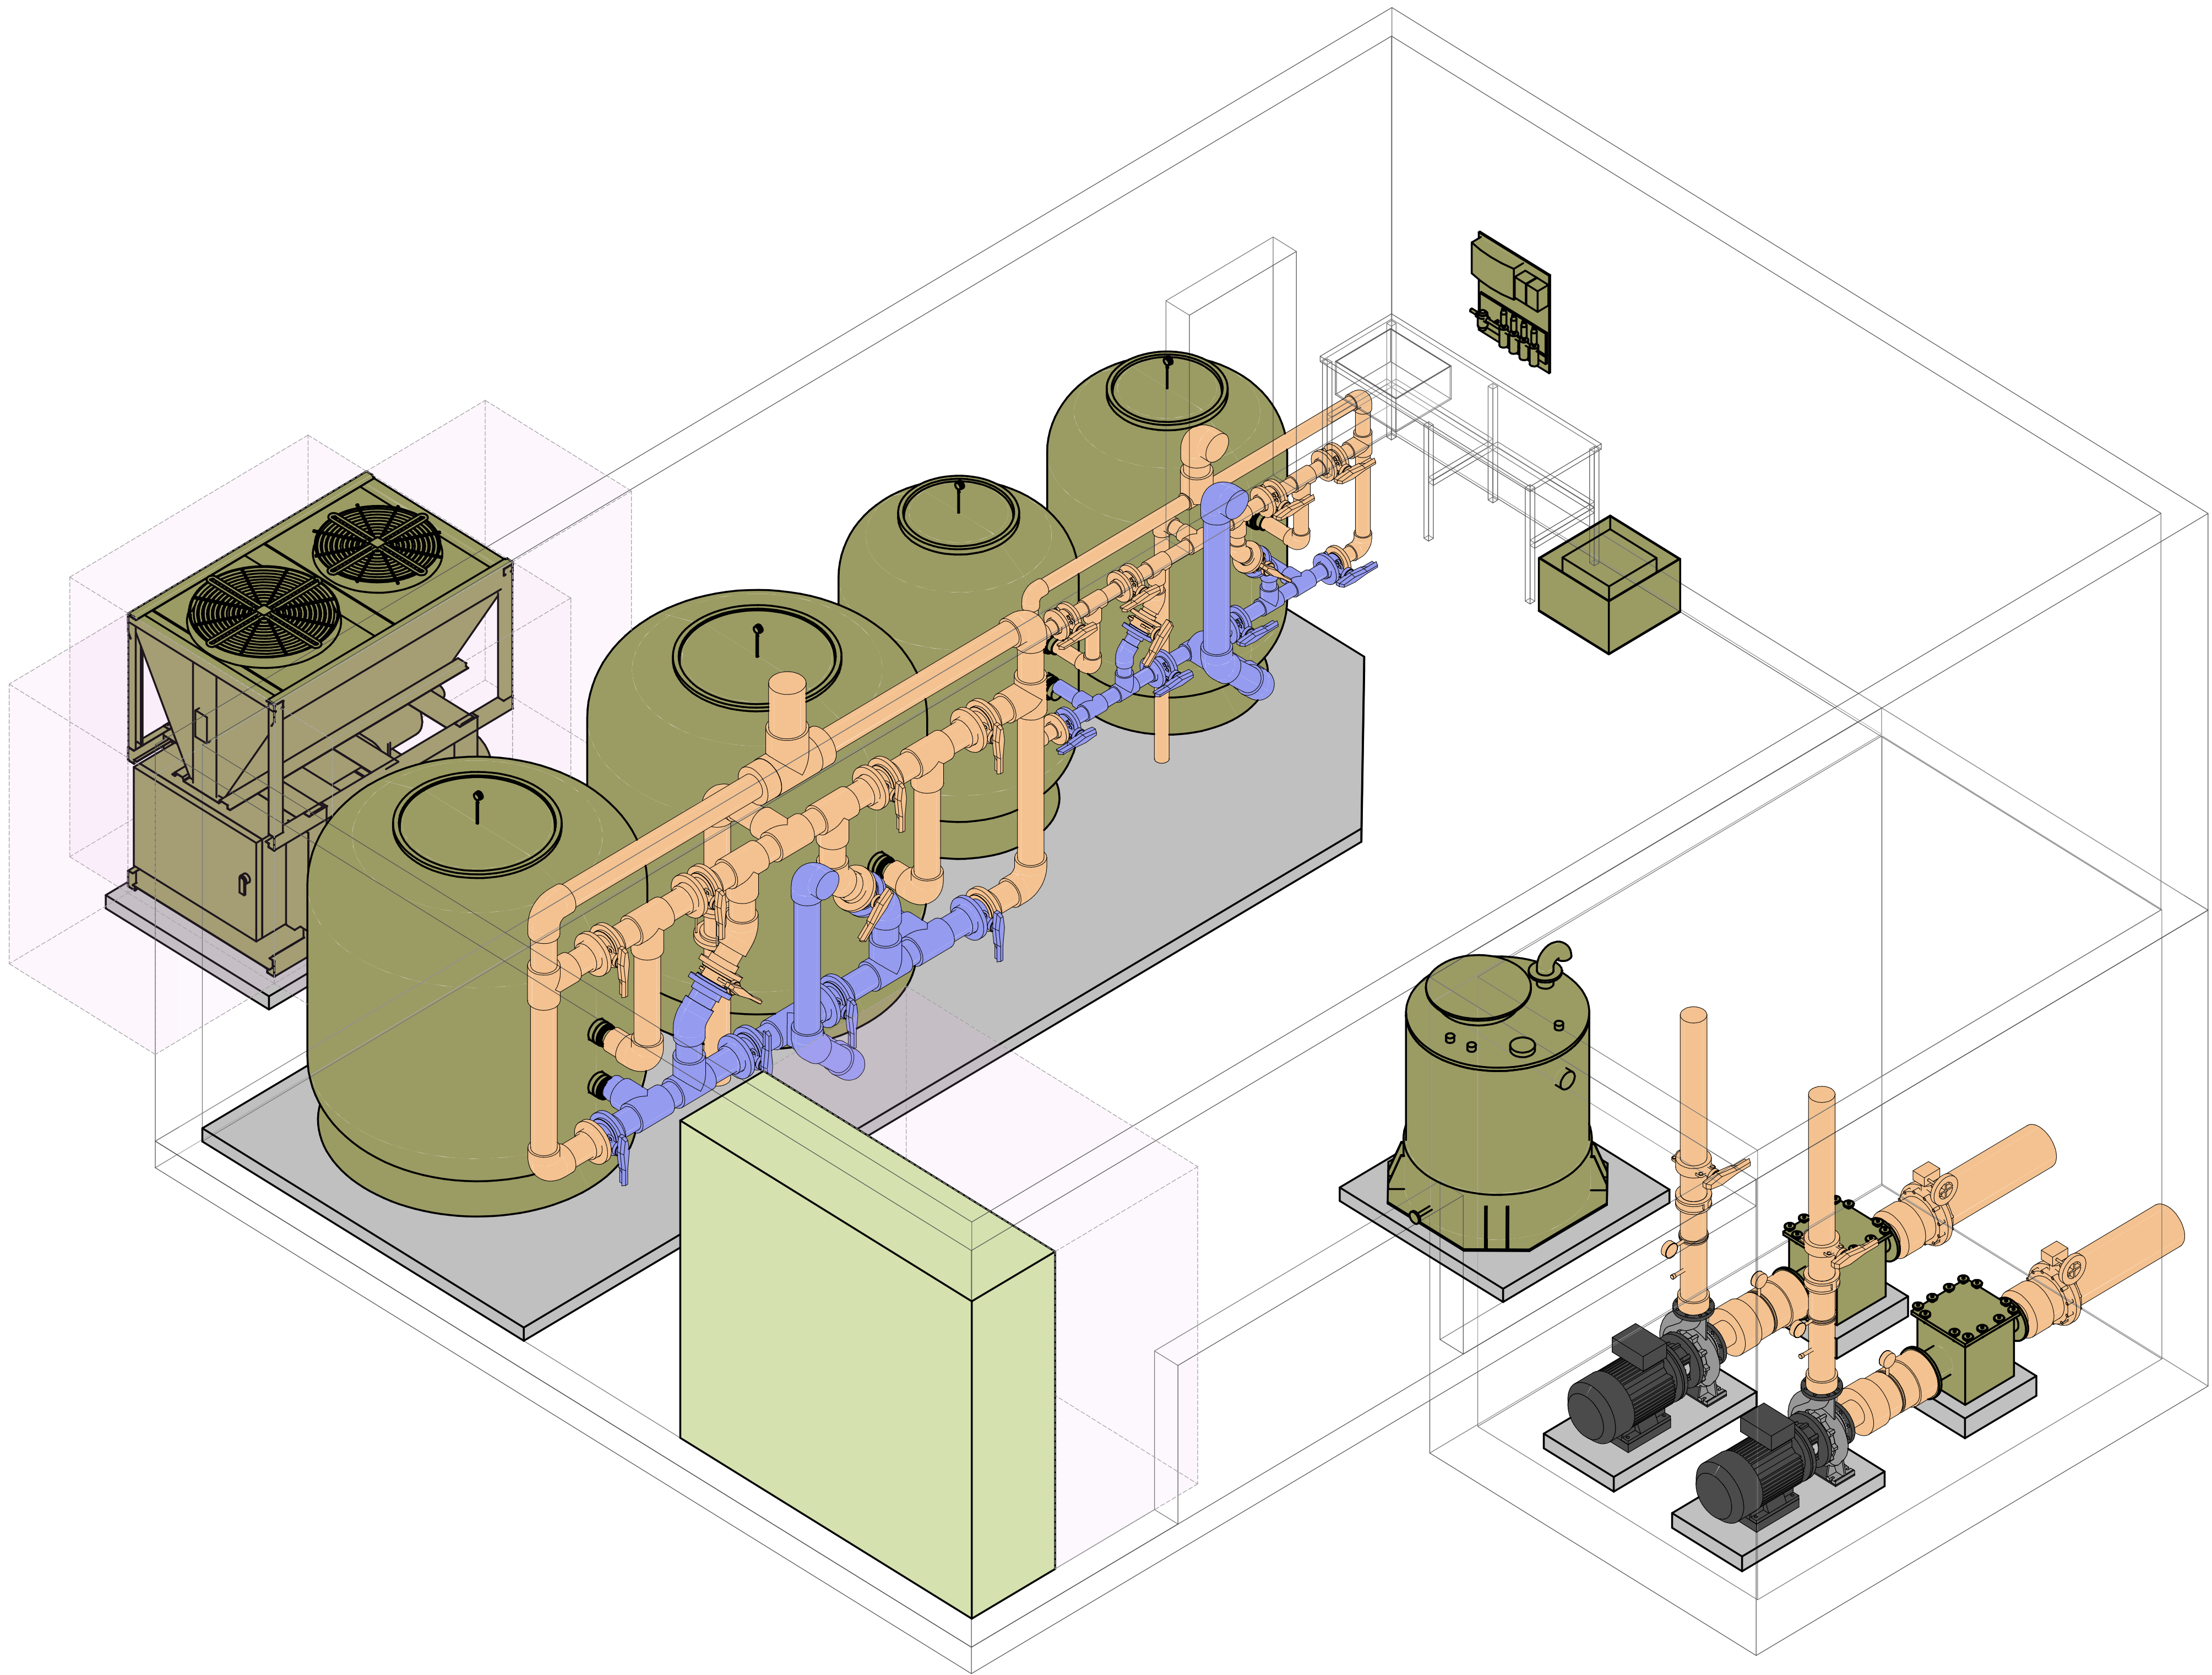


No.	Revision	By	Chk	Appd	Date		

Original Scale (A1)	Design			
	Drawn			
	Disg Verifier			
	Drg Check			
Reduced Scale (A3)				



Client:	Absolutely Positively	
	Wellington City Council	
	Me Heke Ki Pōneke	
Project:	KHANDALLAH POOL	
	REFURBISHMENT	
	45 WOODMANCOTE ROAD, KHANDALLAH.	

Title:	CONCEPTUAL PROPOSED POOL	
	PLANT ROOM VIEW	
Discipline:	POOL WATER SERVICES	
Drawing No:		4294564-BWK-4000
		Rev.

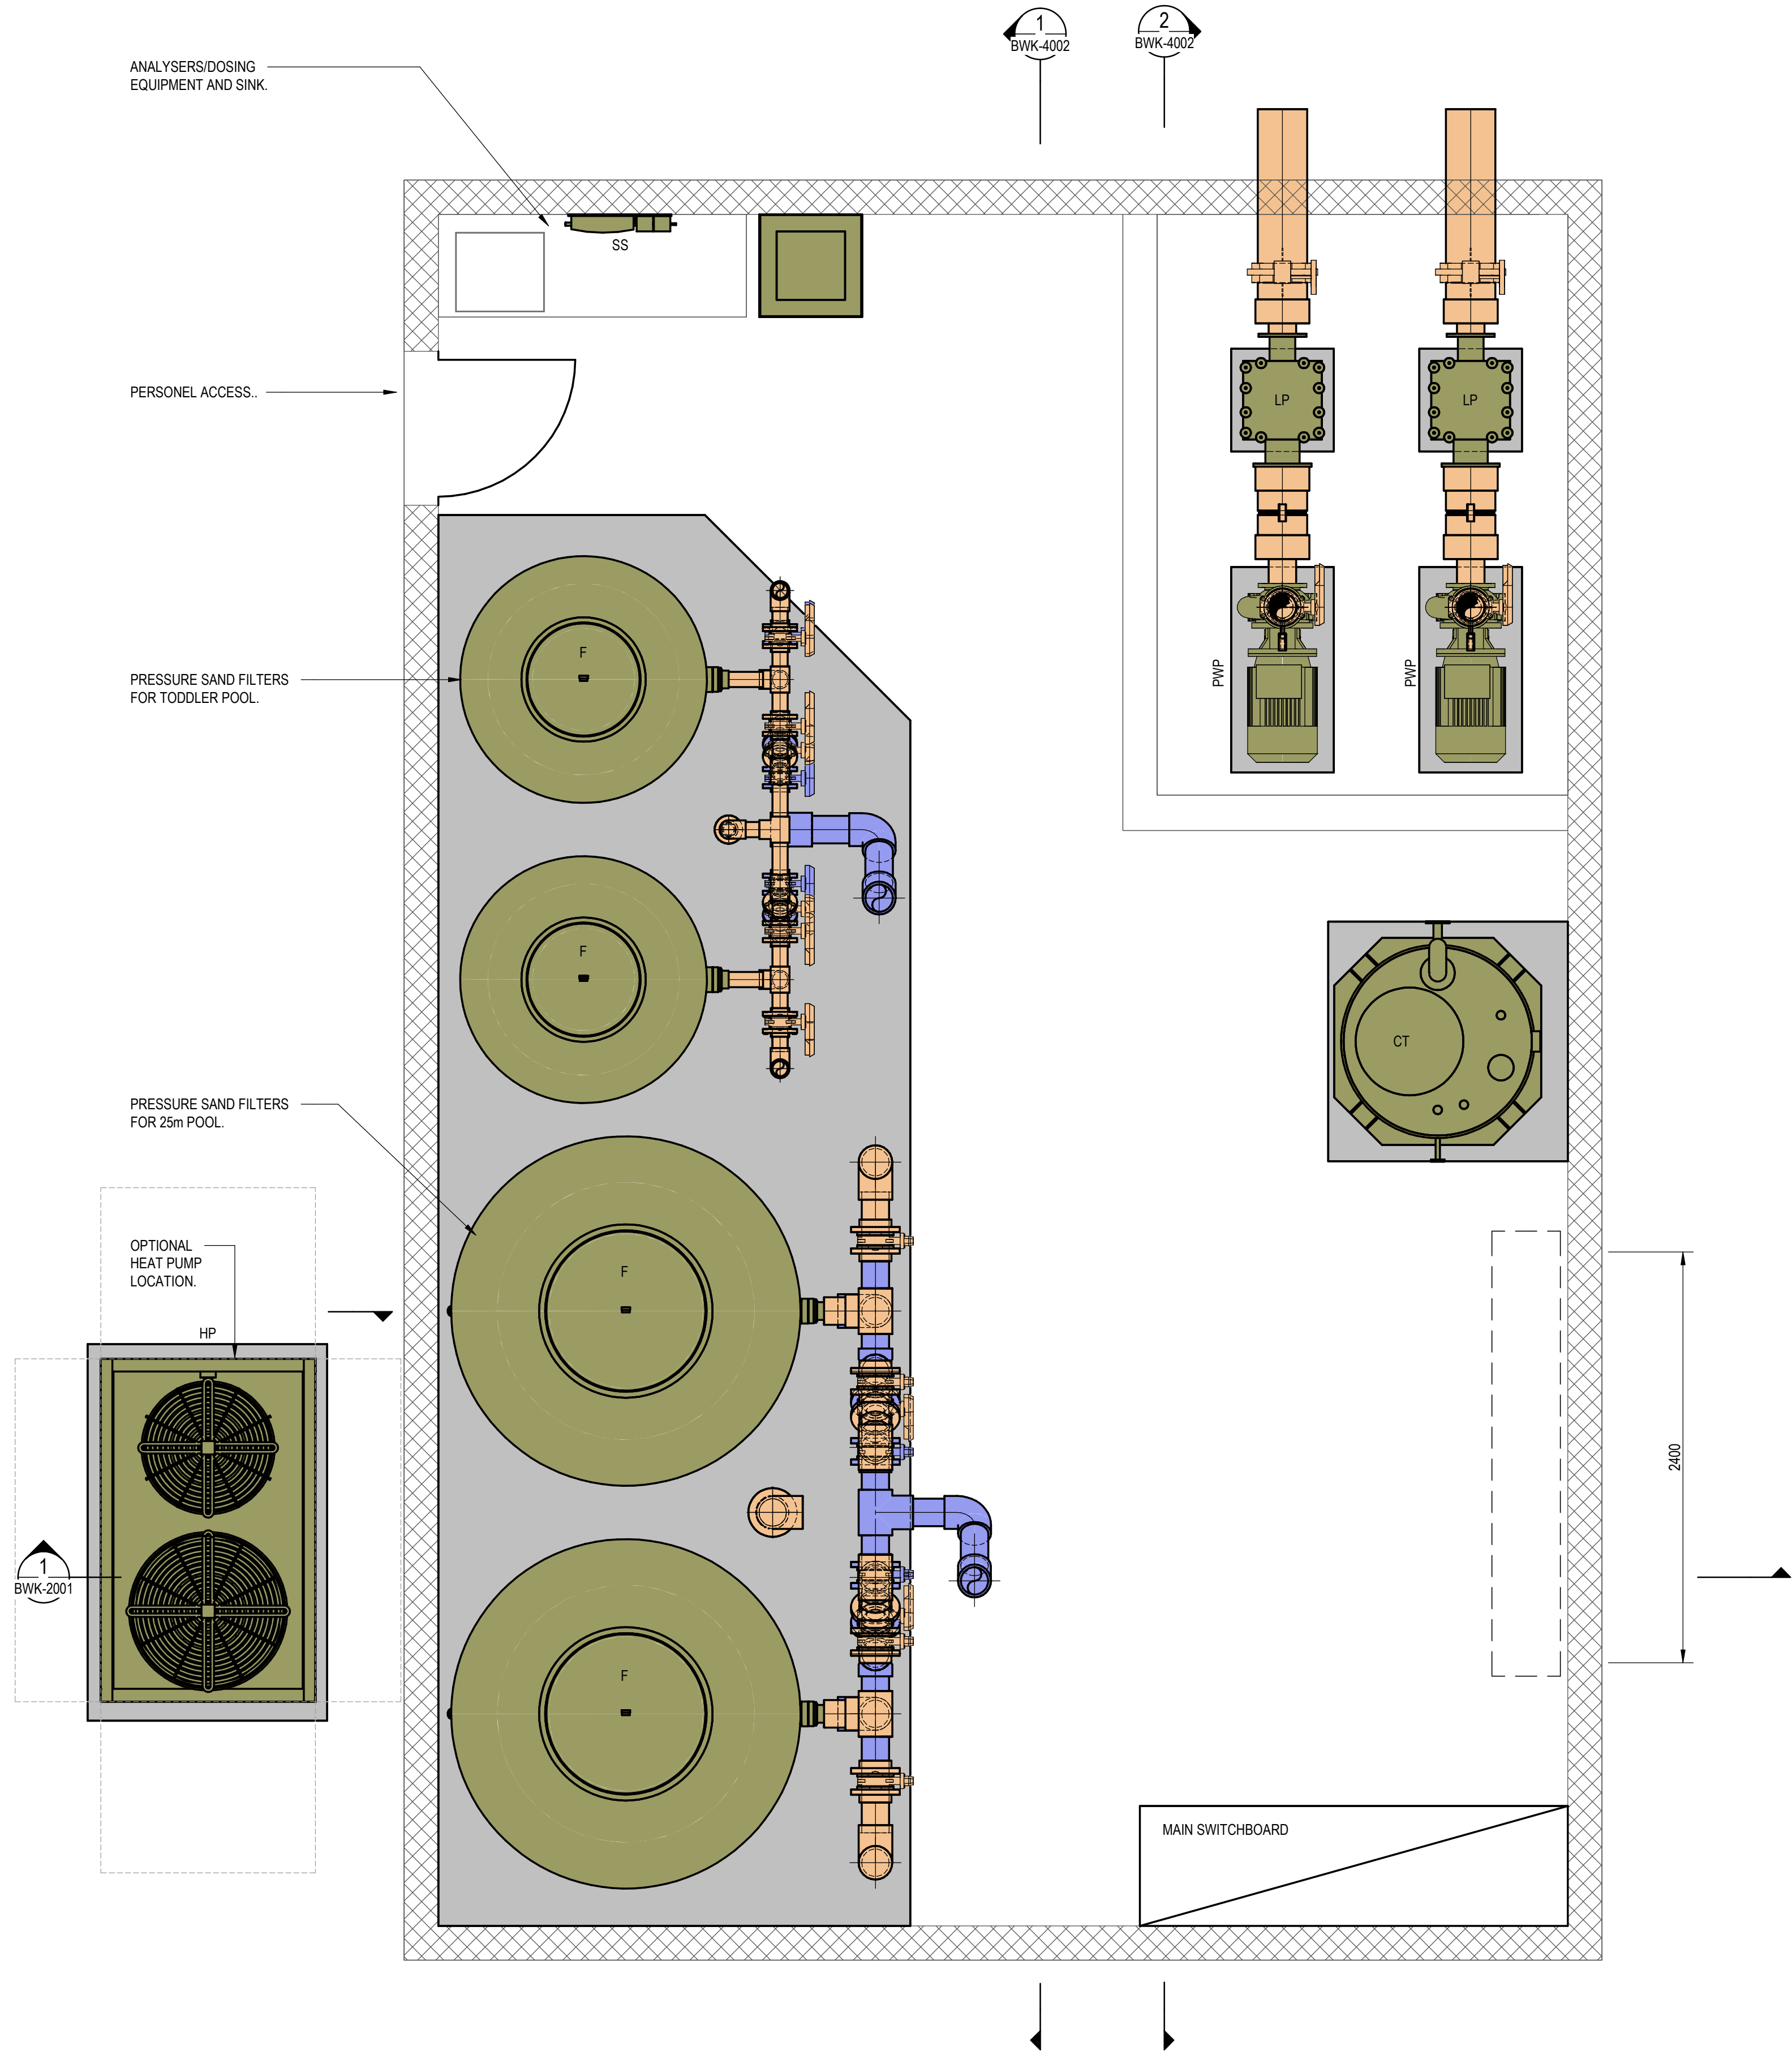

No.	Revision	By	Chk	Appd	Date

Original Scale (A1)	Design			
	Drawn			
Reduced Scale (A3)	Disg Verifier			
	Drg Check			




Client: **Absolutely Positively Wellington City Council**
Me Heke Ki Pōneke

Project: **KHANDALLAH POOL REFURBISHMENT**
45 WOODMANCOTE ROAD, KHANDALLAH.


Title: **CONCEPTUAL PROPOSED POOL PLANT ROOM LAYOUT**

Discipline: POOL WATER SERVICES	Rev.
Drawing No: 4294564-BWK-4001	


DRAFT ONLY
CUSTOM COMMENTS

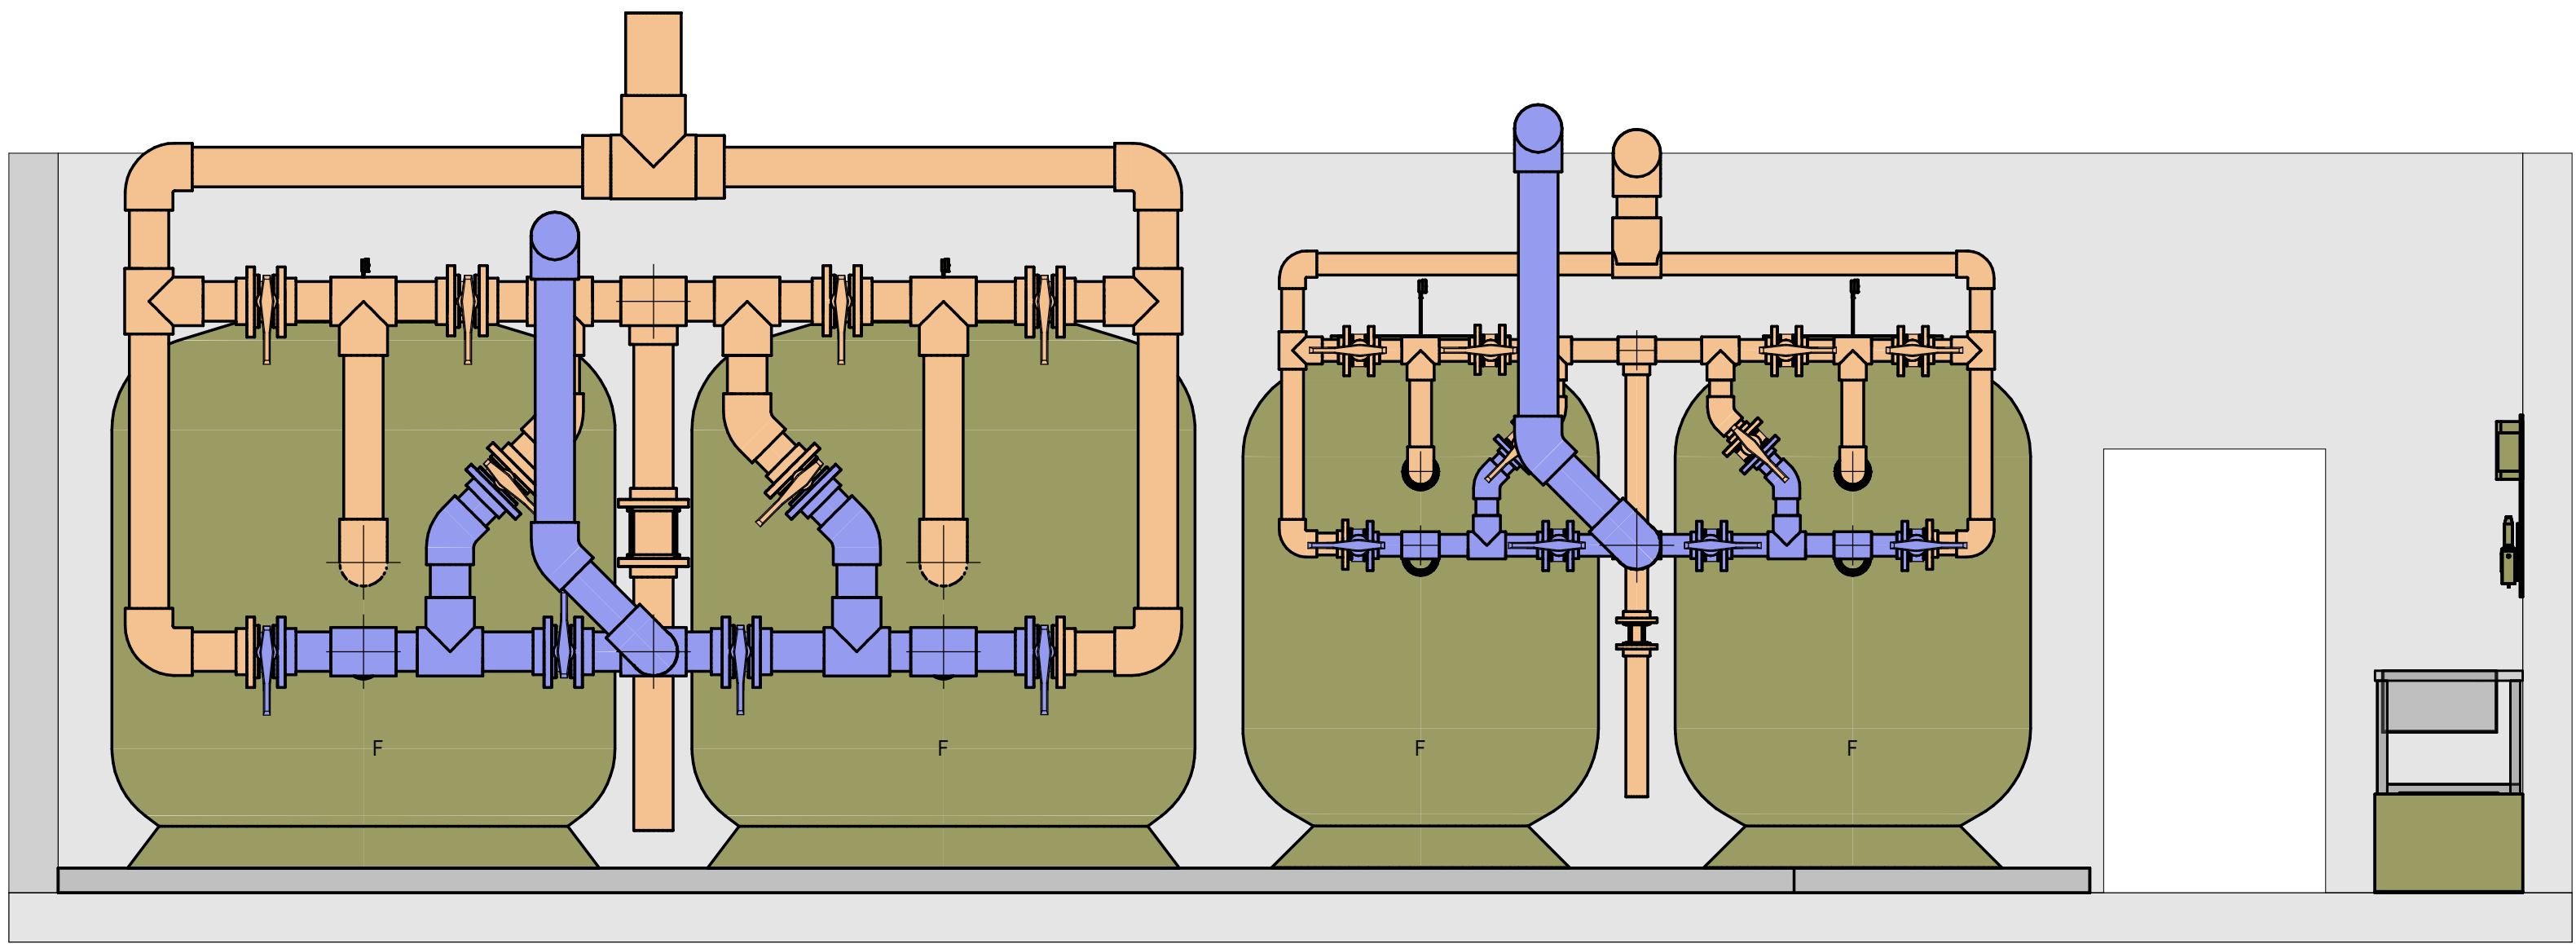

1 FILTER SECTION
BWK-4001 1 : 25

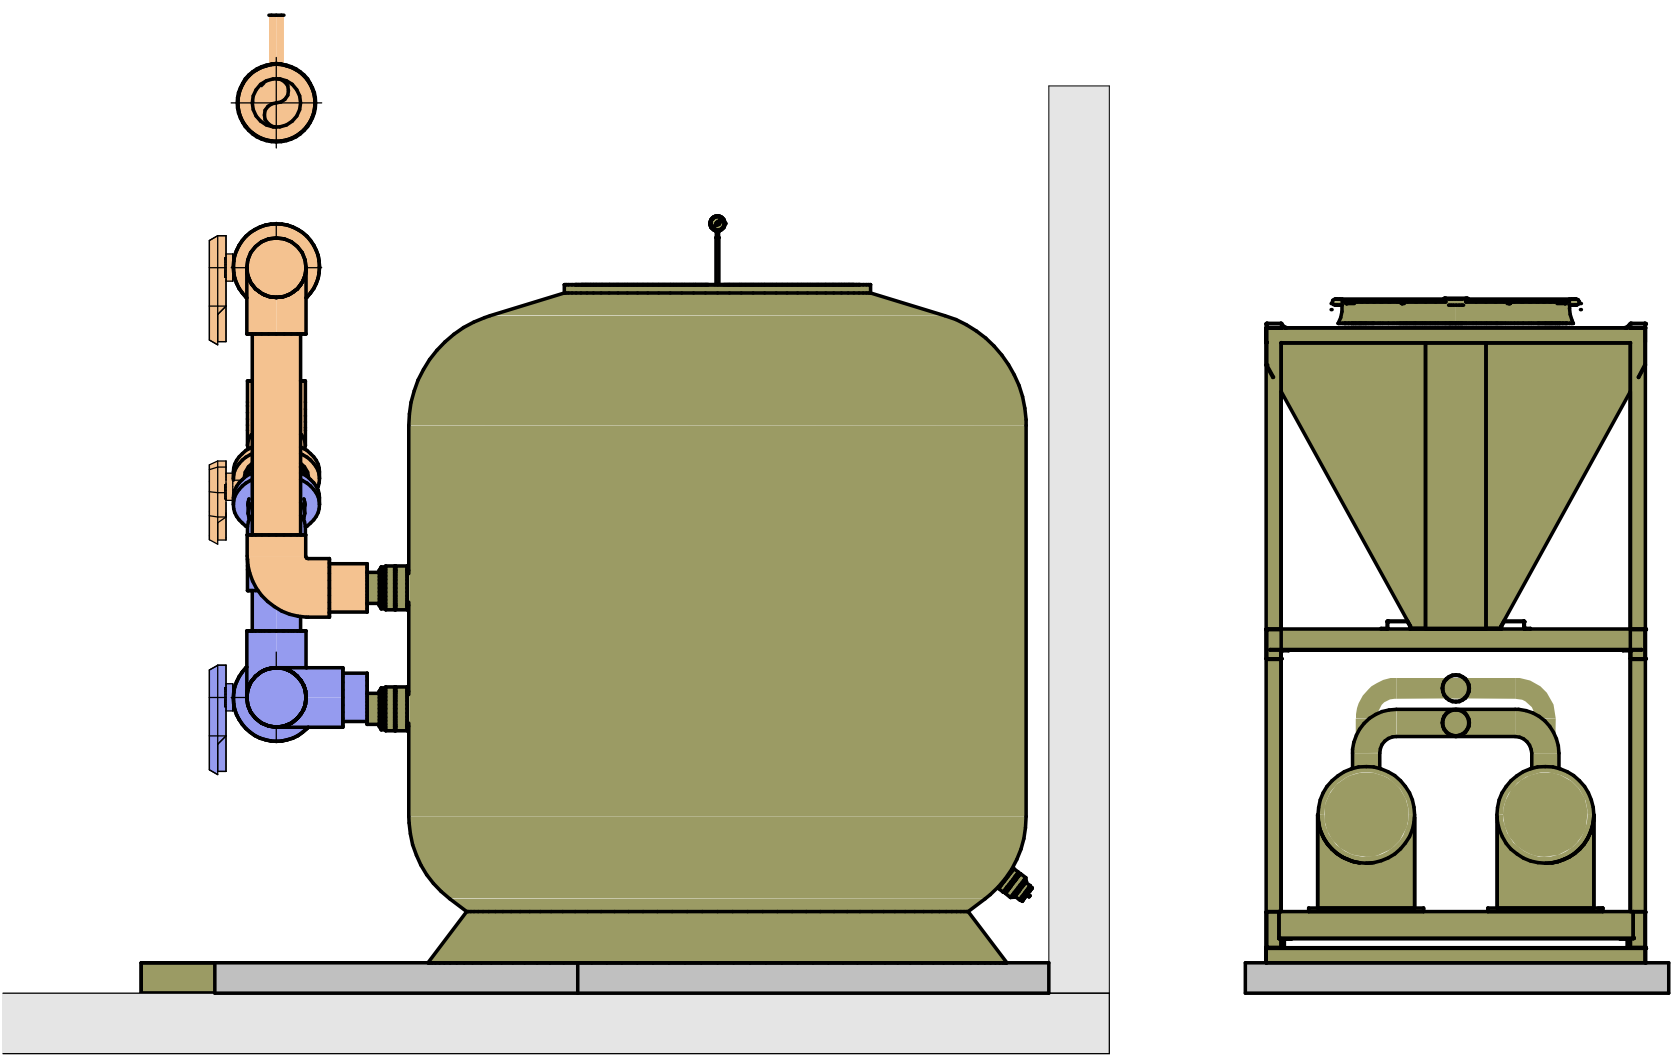

3 HEAT PUMP END SECTION
BWK-4001 1 : 25

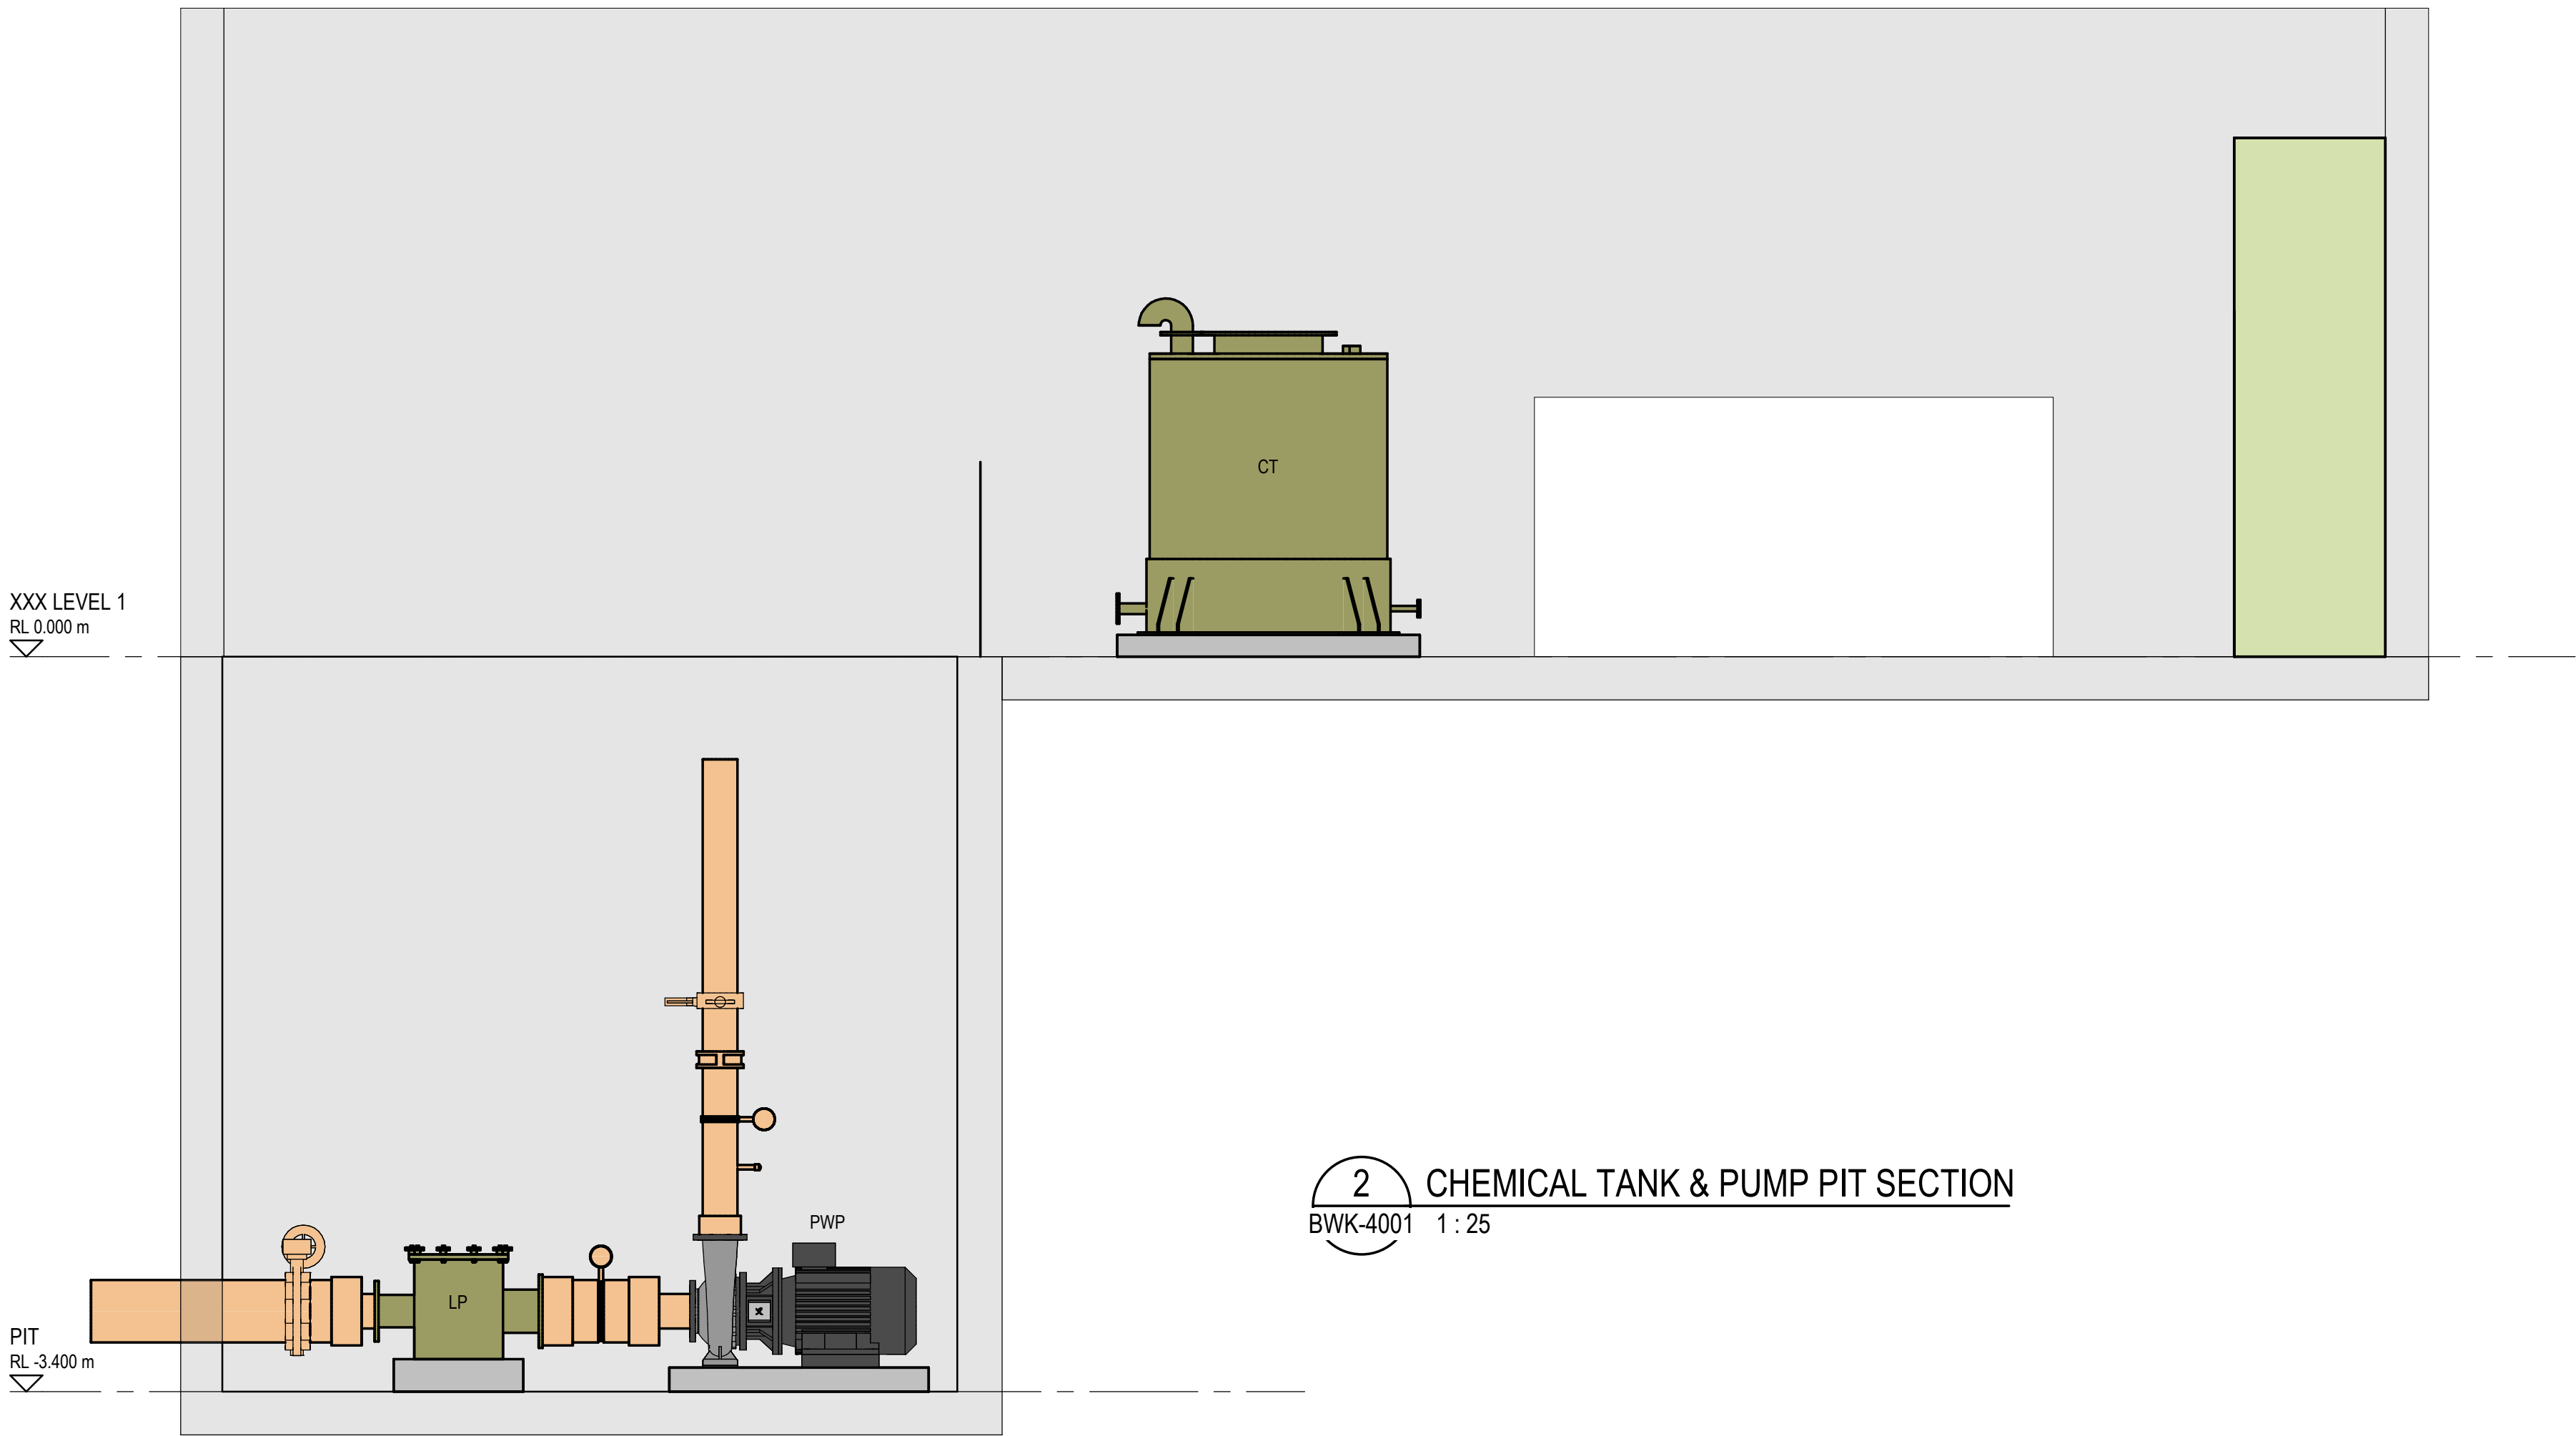

2 CHEMICAL TANK & PUMP PIT SECTION
BWK-4001 1 : 25

No.	Revision	By	Chk	Appd	Date		

Original Scale (A1)	Design				
	Drawn				
Reduced Scale (A3)	Disg Verifier				
	Drg Check				



Client:	Absolutely Positively Wellington City Council Me Heke Ki Pōneke
Project:	KHANDALLAH POOL REFURBISHMENT 45 WOODMANCOTE ROAD, KHANDALLAH.

Title:	CONCEPTUAL PROPOSED PLANT ROOM SECTIONS
Drawing No:	4294564-BWK-4002

Discipline:	POOL WATER SERVICES
Rev.	

DRAFT ONLY
CUSTOM COMMENTS